


JOB No.  
21247.00

BY: MLDEN & HUNT INC  
DATE: CONSULTANTS • ENGINEERS • SURVEYORS  
115 W. McINTYRE - EDINBURG, TX 78541  
PH: (956) 381-0981 - FAX: (956) 381-1639  
ESTABLISHED 1947 - www.meldenandhunt.com

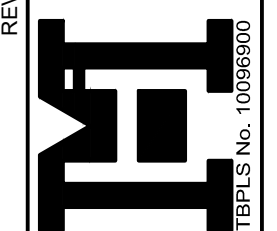

ENG. TECH. EM  
PROJECT ENG. M.A.R.  
T-BOOK: P.G.  
1. RELEASE DATE:  
2. RELEASE DATE:  
3. RELEASE DATE:  
SCALE: NOT TO SCALE

THIS DOCUMENT IS RELEASED FOR THE PURPOSE OF INTERIM REVIEW ONLY. IT IS NOT TO BE USED FOR PERMITTING, BIDDING OR PERMIT PURPOSES.

LONDON COVES  
SUBDIVISION  
CORPUS CHRISTI, TEXAS

OVERALL MASTER  
DRAINAGE LAYOUT


Copyright 2023 Melden & Hunt, Inc.  
All Rights Reserved.

File Name: XXXXXXXXXXX

SHEET 1 OF 5


Y:\Land Development\Residential\Corpus Christi\240225 - London Coves - Rides\Autocad\100 Storm.dwg, 2/21/2024, 2:44:59 PM, DWG to PDF job3



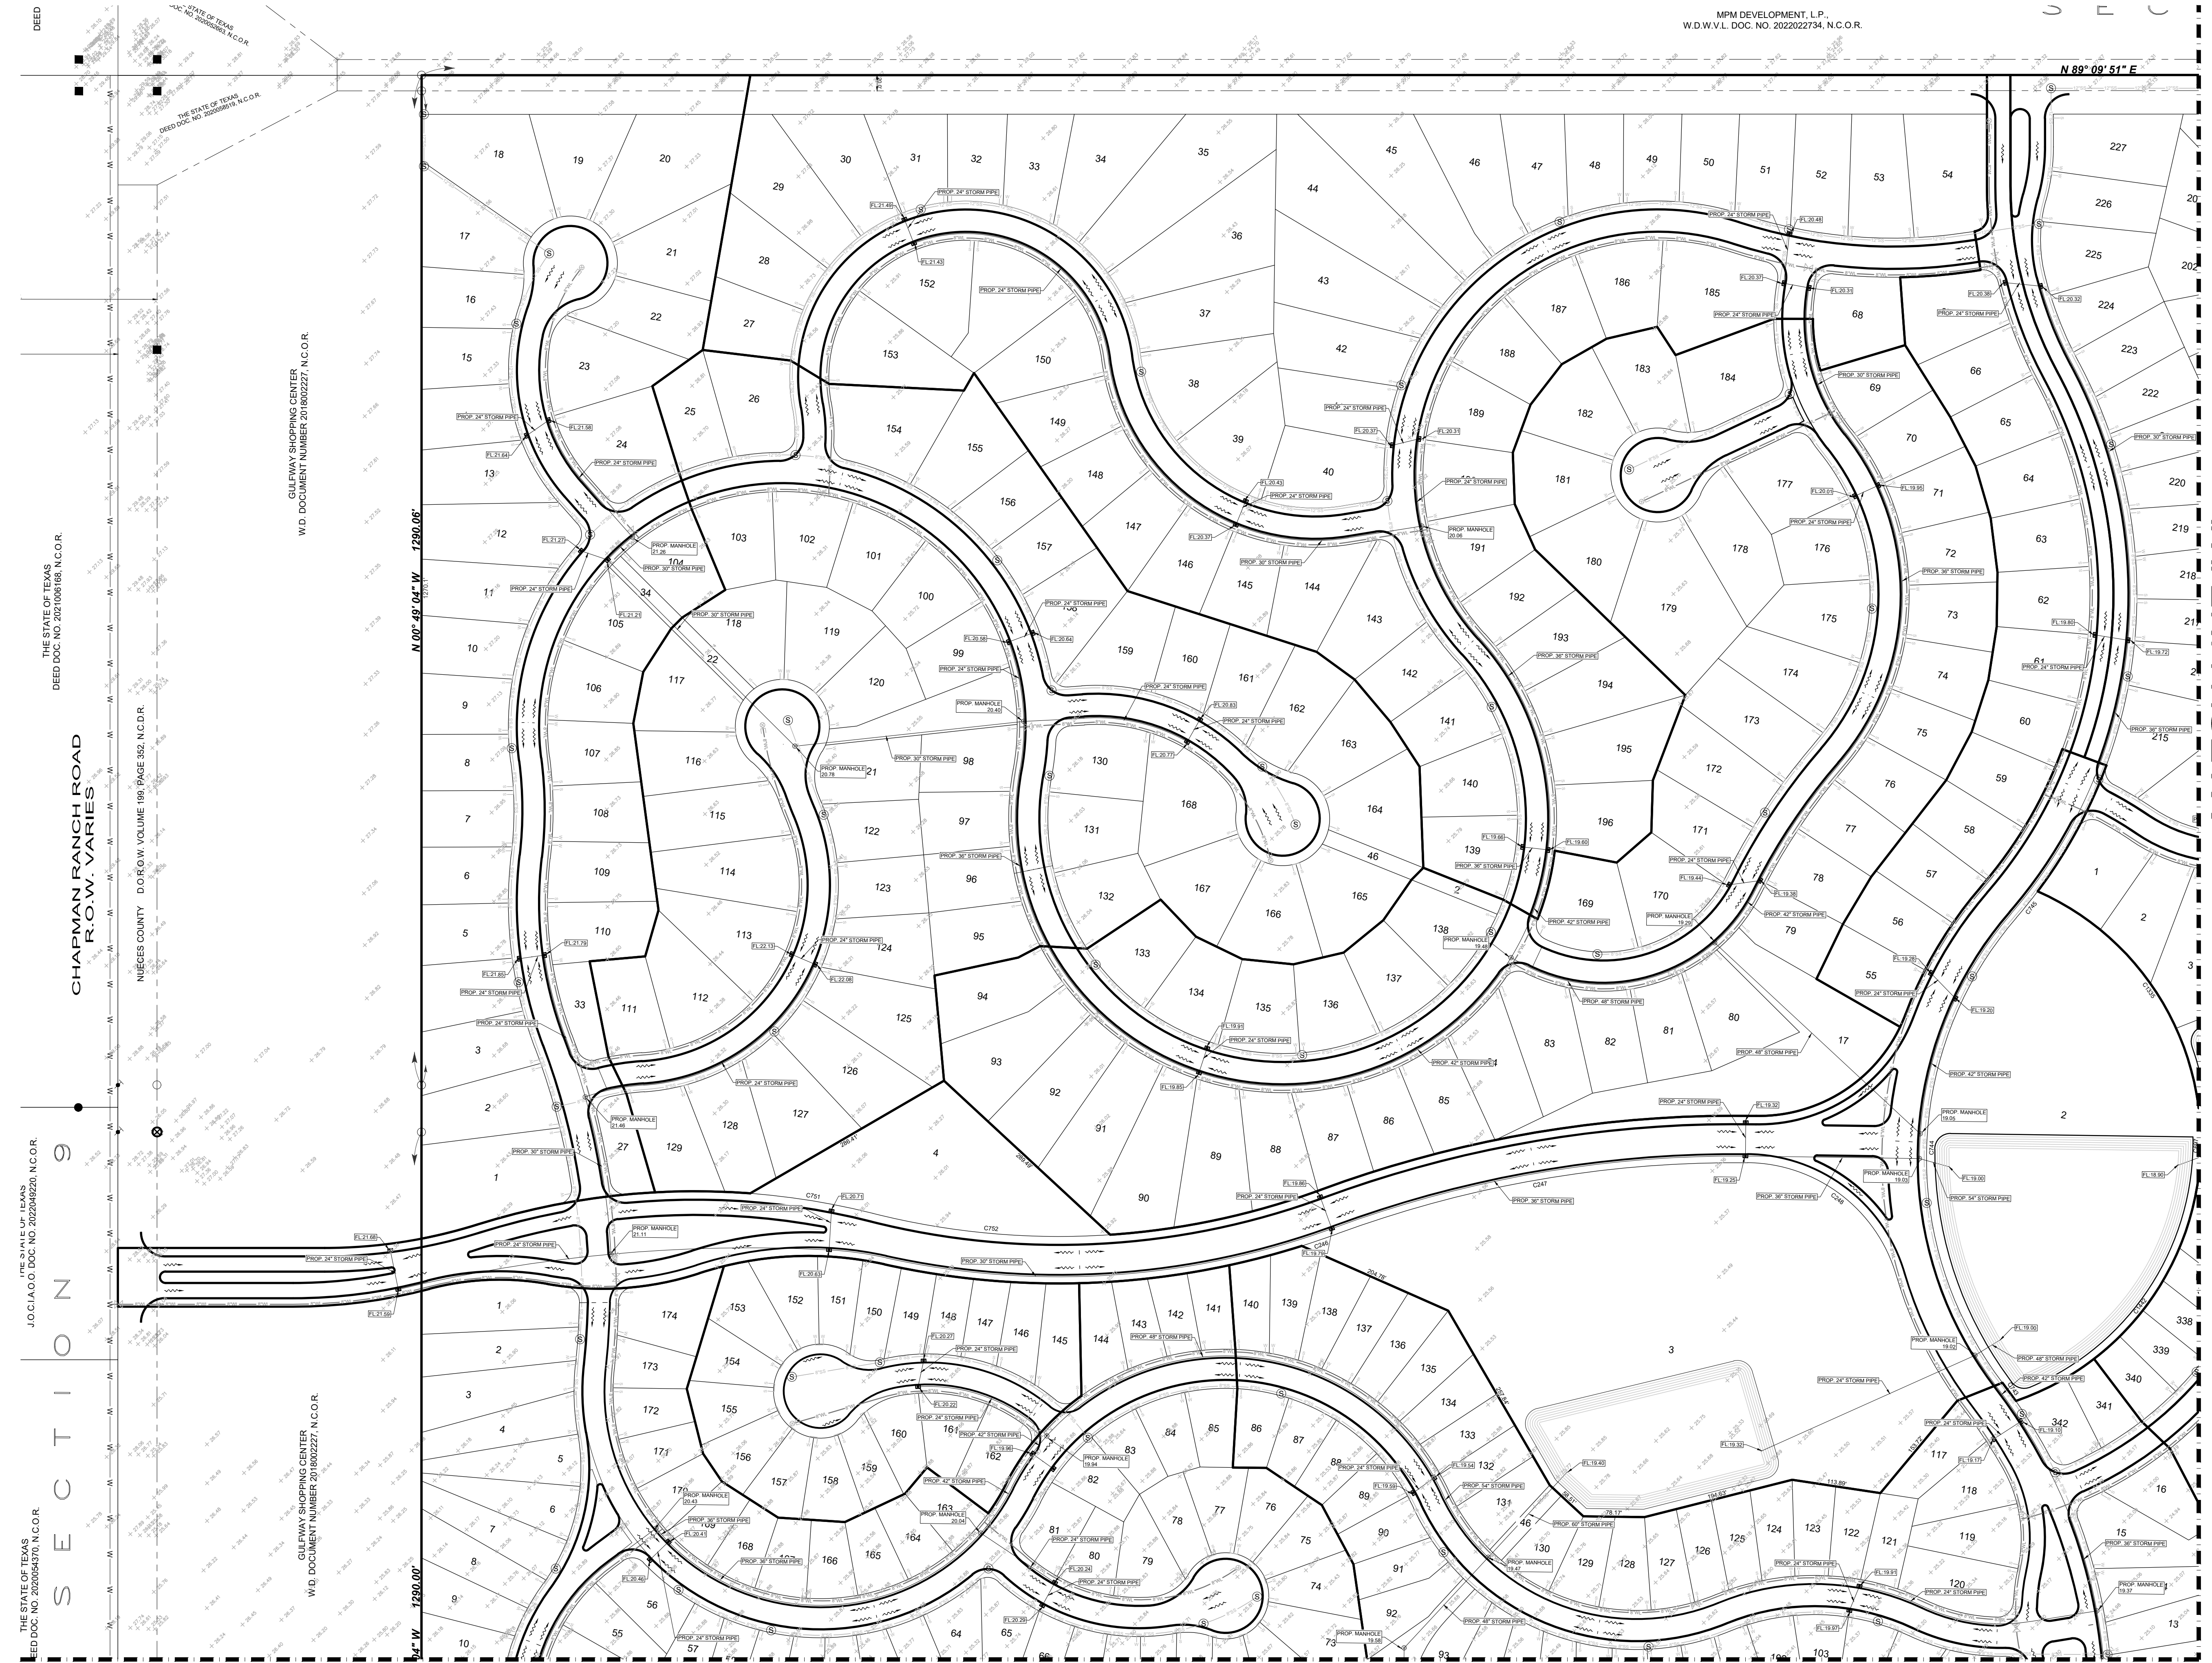

THE STATE OF TEXAS  
 DEED DOC. NO. 202004370, N.C.O.R.  
 THE STATE OF TEXAS  
 DEED DOC. NO. 2022049220, N.C.O.R.  
 THE STATE OF TEXAS  
 DEED DOC. NO. 202106168, N.C.O.R.  
 CHAPMAN RANCH ROAD  
 R.O.W. VARIES  
 NIUECES COUNTY D.O.R. (O.W. VOLUME 198, PAGE 352, N.C.D.R.  
 GULFWAY SHOPPING CENTER  
 W.D. DOCUMENT NUMBER 201800227, N.C.O.R.  
 GULFWAY SHOPPING CENTER  
 W.D. DOCUMENT NUMBER 201800227, N.C.O.R.  
 GULFWAY SHOPPING CENTER  
 W.D. DOCUMENT NUMBER 201800227, N.C.O.R.  
 DEED

MPM DEVELOPMENT, L.P.  
 W.D.W.V.L. DOC. NO. 2022022734, N.C.O.R.

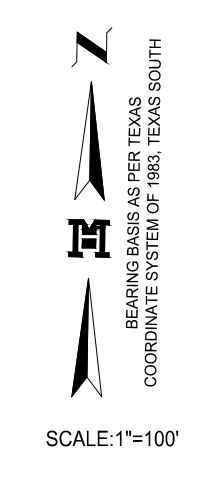

MATCH LINE "A"

MATCH LINE "C"

JOB No.  
21247.00

REVISION	DATE	BY
 <b>MELDEN &amp; HUNT INC.</b> CONSULTANTS - ENGINEERS - SURVEYORS 1145 W. MANTYBEE - FORT WORTH, TX 76164 PH: (817) 381-0881 - FAX: (817) 381-1839 ESTABLISHED 1947 - www.meldenhunt.com EPLS No. 10896900		

ENG. TECH: EM	PROJECT ENG: M.A.R.
T-BOOK: .JPG	1. RELEASE DATE:
	2. RELEASE DATE:
	3. RELEASE DATE:
SCALE: AS SHOWN	


THIS DOCUMENT IS RELEASED  
 FOR THE PURPOSE OF INTERIM  
 REVIEW ONLY. IT IS NOT TO BE  
 USED FOR CONSTRUCTION,  
 BIDDING OR PERMIT PURPOSES.

**LONDON COVES  
 SUBDIVISION**  
 CORPUS CHRISTI, TEXAS

**MASTER DRAINAGE  
 LAYOUT**

Y:\Land Development\Residential\Corpus Christi\240227 - London Coves - Rhonda Autocad File\Storm.dwg, 2/21/2024, 2:46:54 PM, DWG to PDF.pc3



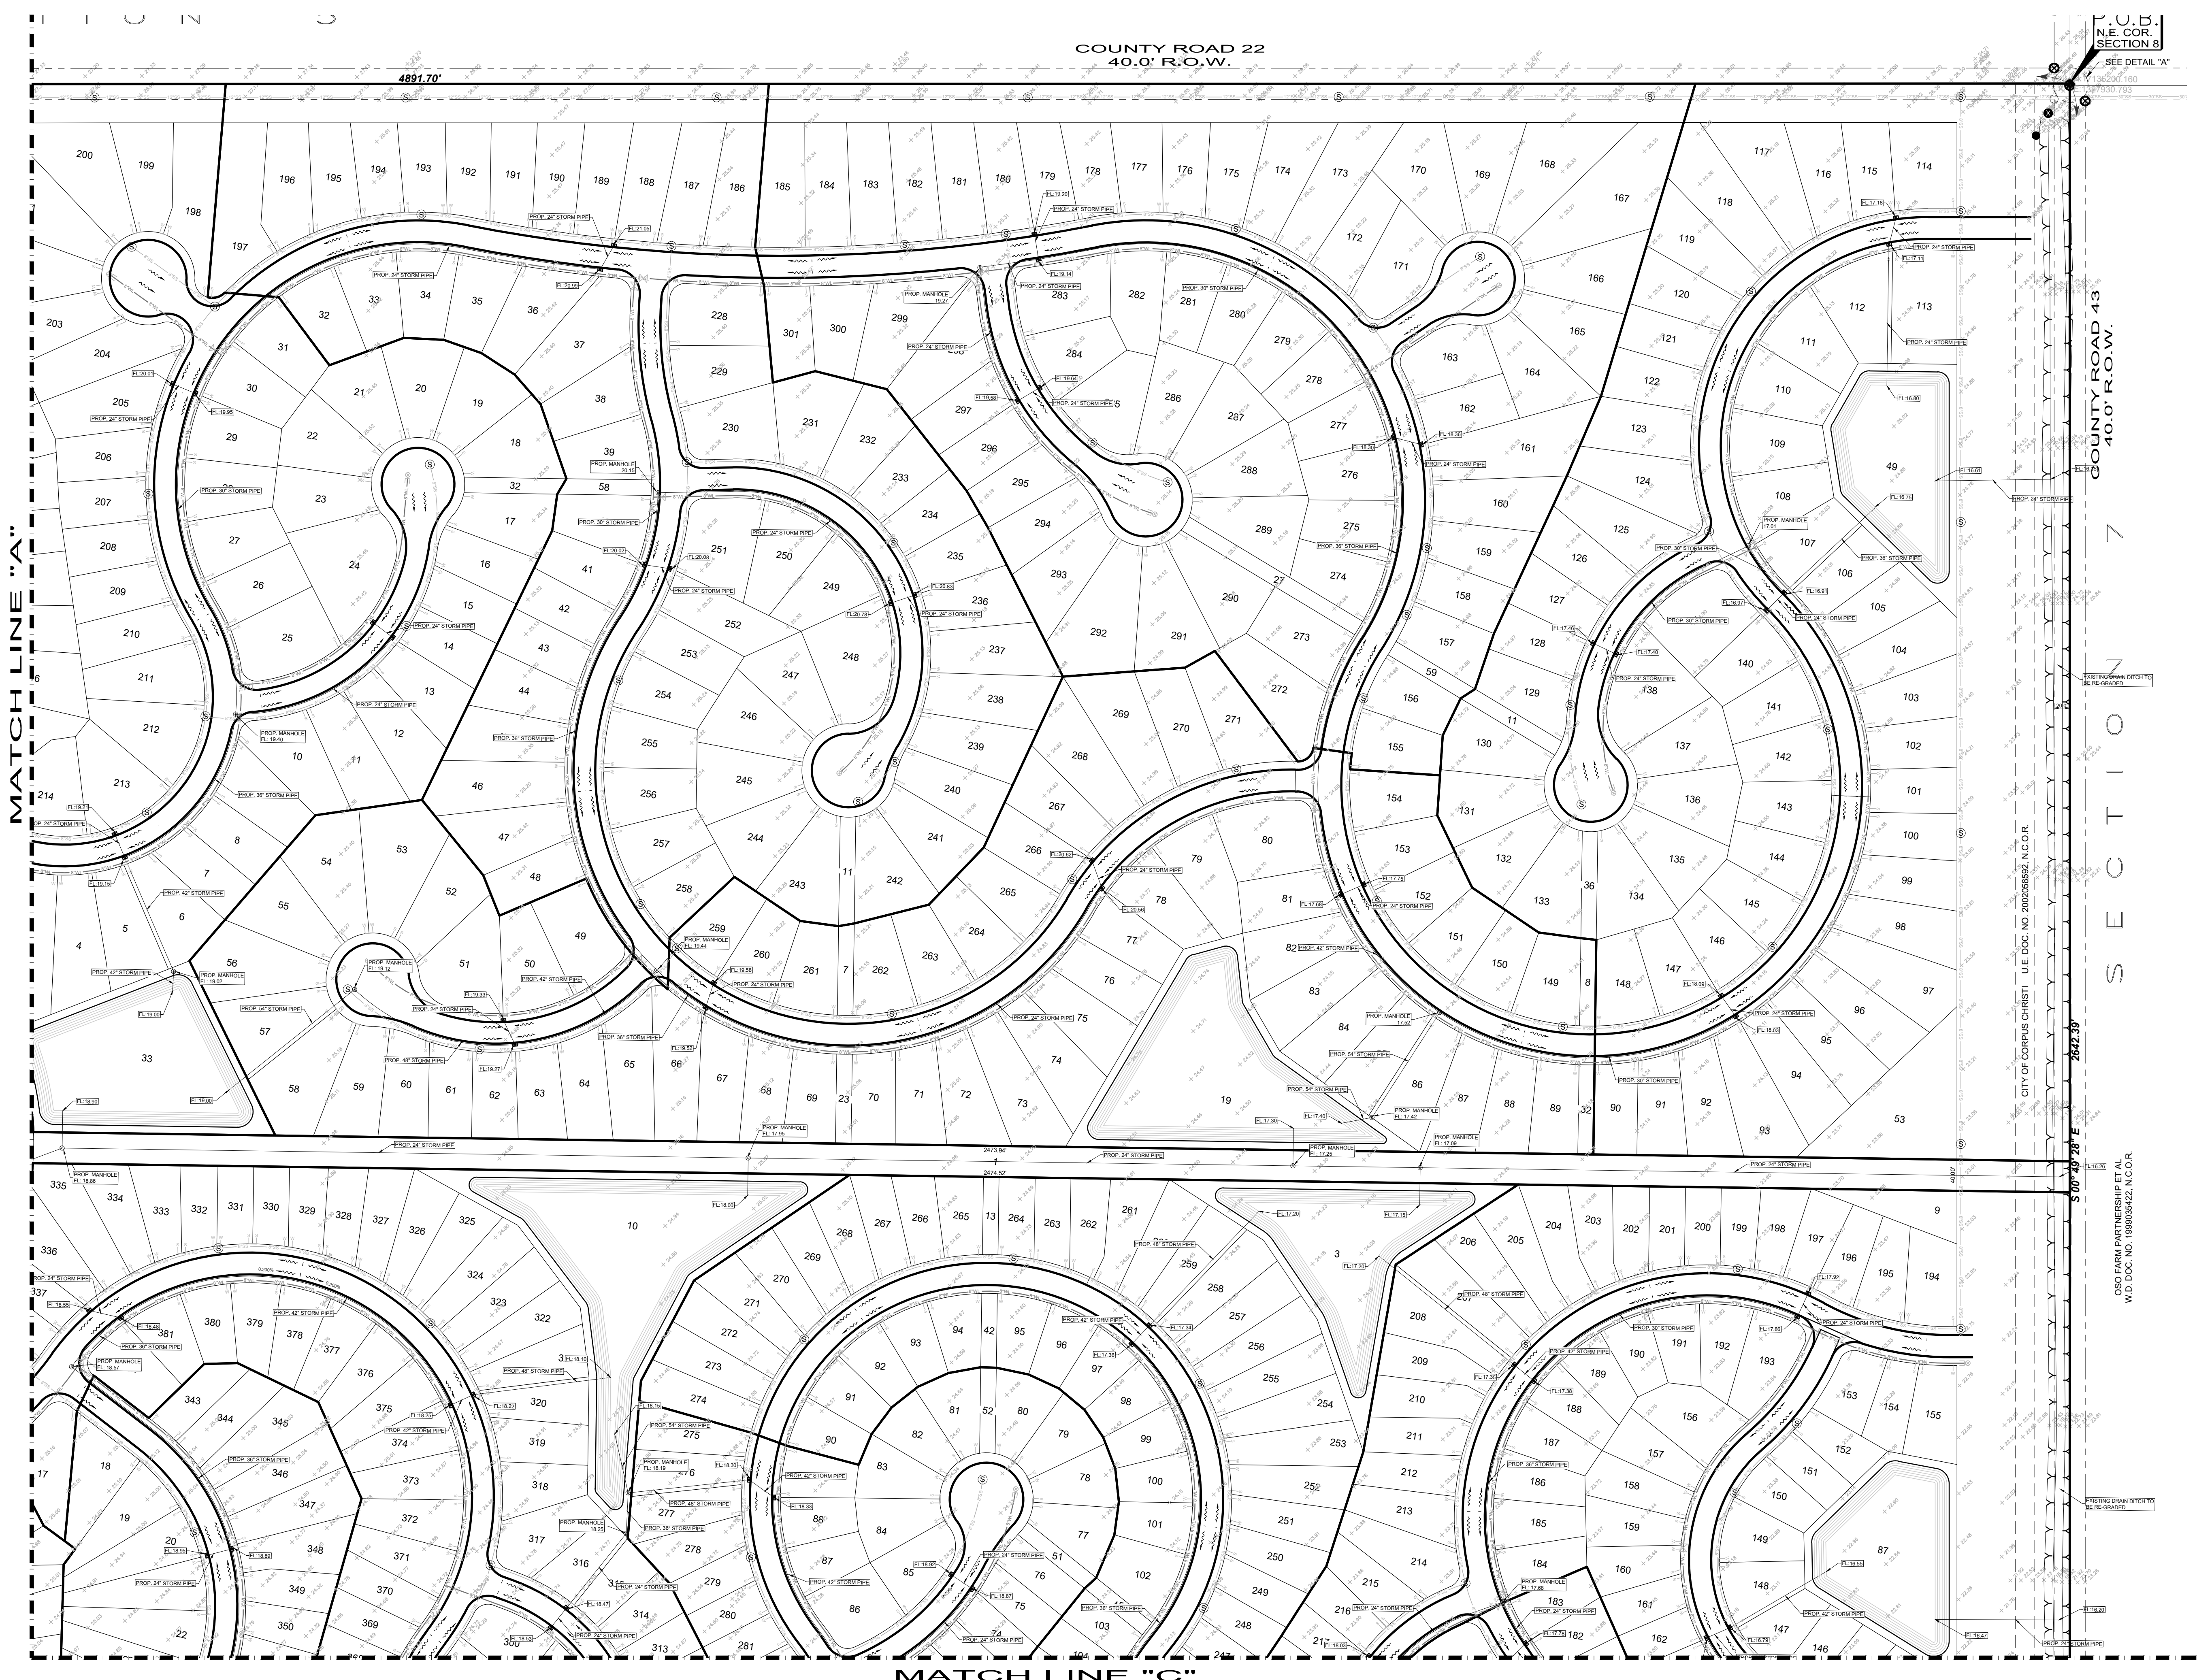

COUNTY ROAD 22  
40.0' R.O.W.

N.C.C.B.  
N.E. COR.  
SECTION 8

SEE DETAIL "A"

COUNTY ROAD 43  
40.0' R.O.W.

SECTION 7


CITY OF CORPUS CHRISTI U.E. DOC. NO. 202005802 N.C.O.R.

S 0° 09' 28" E

2642.39'

CGS PLANNING ENGINEERS, P.C.  
W.D. DOC. NO. 180008422 N.C.O.R.

EXISTING DRAINAGE TO  
BE RE-GRABBED

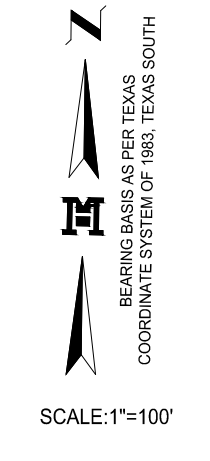

JOB No.  
21247.00

REVISION BY DATE

**MELDEN & HUNT INC.**  
CONSULTANTS • ENGINEERS • SURVEYORS  
115 W. MCINTYRE - EDINBURG, TX 78541  
PH: (956) 381-0981 - FAX: (956) 381-1839  
ESTABLISHED 1947 - www.meldenhunt.com

ENG. TECH. EM	PROJECT ENG. M.A.R.
T-BOOK: PG.	1. RELEASE DATE:
2. RELEASE DATE:	3. RELEASE DATE:
SCALE:	AS SHOWN

THIS DOCUMENT IS RELEASED FOR THE PURPOSE OF INTEREST OF KELLEY A. HELLER-VELA P.E. 117268 ON NOVEMBER 30, 2023. IT IS NOT TO BE USED FOR ANY OTHER BIDDING OR PERMIT PURPOSES.

**LONDON COVES SUBDIVISION**  
CORPUS CHRISTI, TEXAS

**MASTER DRAINAGE LAYOUT**



© Copyright 2023 Melden & Hunt, Inc.  
All Rights Reserved

File Name: XXXXXXXXXX

SHEET 2 OF 5

Y:\Land Development\Residential\Corpus Christi\240223 - London Coves - Roshes\Autocad - Roshes\Autocad - Roshes\Storm.dwg, 2/21/2024, 2:47:19 PM, DWG, Is, PDF, pcd



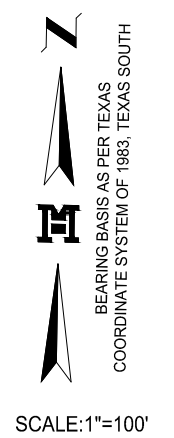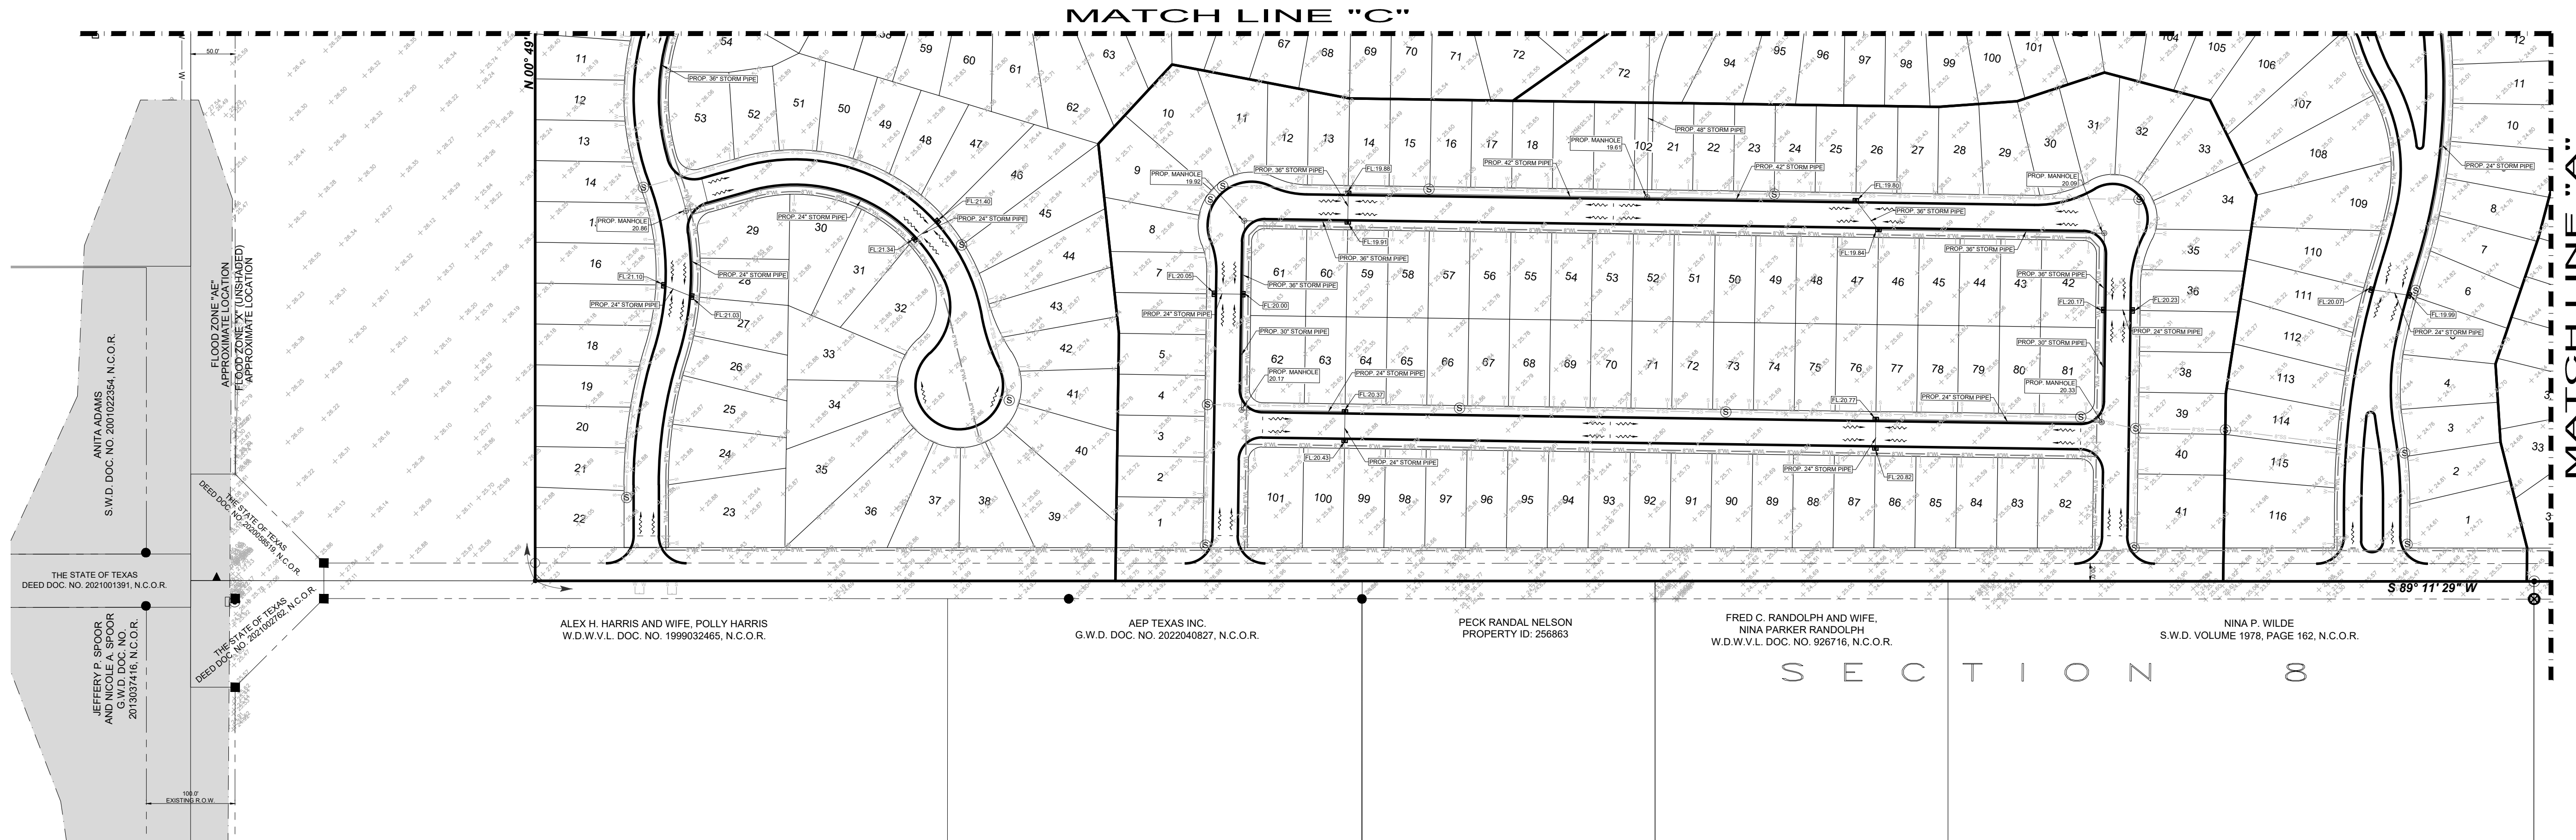

JOB No.  
21247.00

REVISION  
DATE  
BY  
**MELDEN & HUNT INC.**  
CONSULTANTS • ENGINEERS • SURVEYORS  
115 W. MCINTYRE - EDINBURG, TX 78541  
P.O. BOX 1009890  
ESTABLISHED 1947 - www.meldenhunt.com

ENG. TECH. EM  
PROJECT ENG. M.A.R.  
T.BOOK . PG.  
1. RELEASE DATE:  
2. RELEASE DATE:  
3. RELEASE DATE:  
SCALE: AS SHOWN

THIS DOCUMENT IS RELEASED FOR THE PURPOSE OF INTERIM REVIEW UNDER THE AUTHORITY OF NOVEMBER 30, 2023. IT IS NOT TO BE USED FOR CONSTRUCTION, BIDDING OR PERMIT PURPOSES.



**LONDON COVES  
SUBDIVISION**  
CORPUS CHRISTI, TEXAS

**MASTER DRAINAGE  
LAYOUT**

Copyright 2023 Melden & Hunt, Inc.  
All Rights Reserved.  
File Name: XXXXXXXXXX  
SHEET 3 OF 5

Y:\Land Development\Residential\Corpus Christi\240223 - London Coves - Rhodes\Autocad files\Storm.dwg, 2/21/2024, 2:47:45 PM, DWG to PDF.plt

REVISION	DATE	BY
<b>MELDEN &amp; HUNT INC</b>		
CONSULTANTS • ENGINEERS • SURVEYORS		
145 W. MUNTYDALE • EDINBURG, TX 78541 PH: (956) 381-0981 • FAX: (956) 381-1859 ESTABLISHED 1947 • www.meldenandhunt.com		

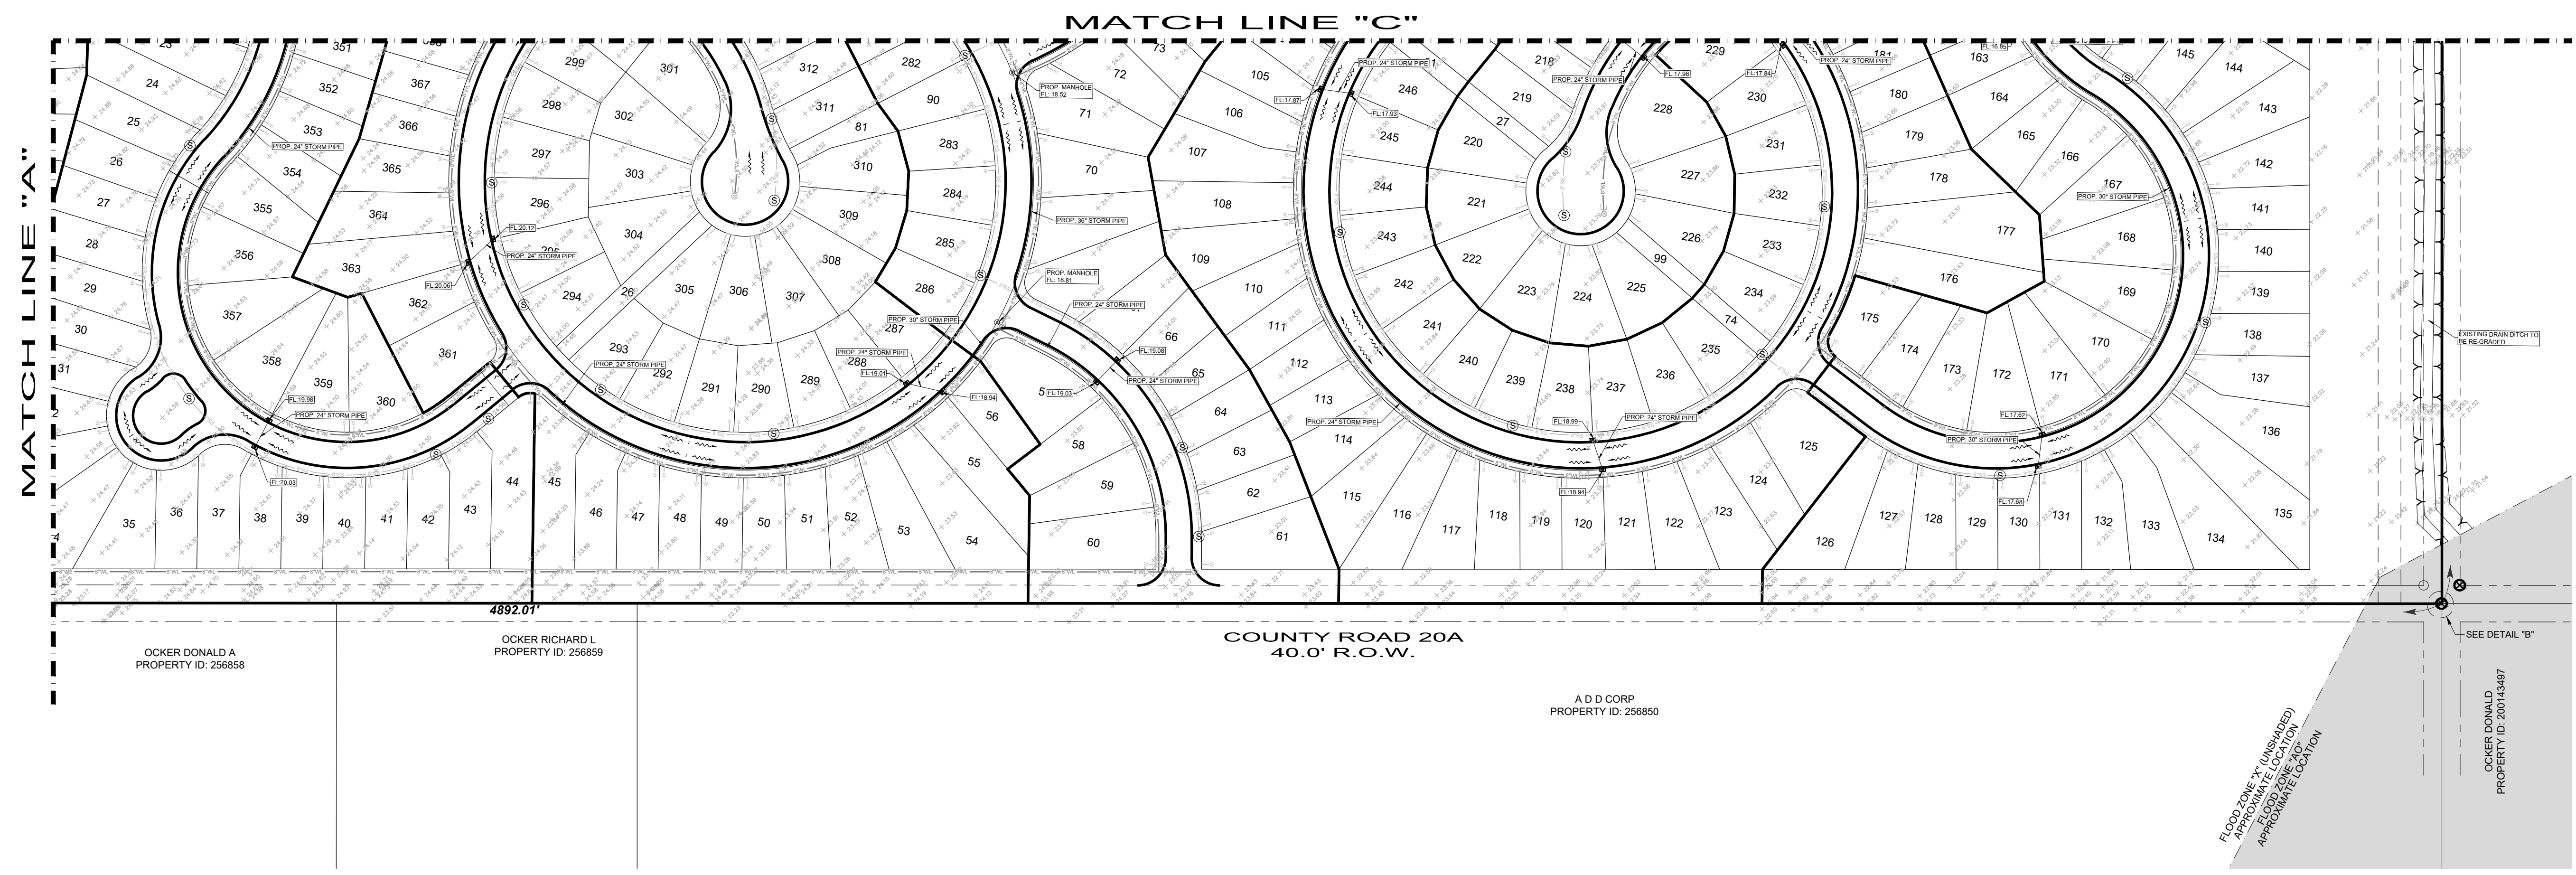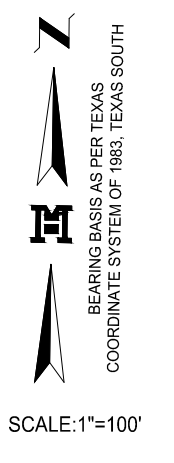

ENG. TECH. EM	PROJECT ENG. M.A.R.
T.BOOK	1. PG.
1. RELEASE DATE:	
2. RELEASE DATE:	
3. RELEASE DATE:	
SCALE:	AS SHOWN

THIS DOCUMENT IS RELEASED FOR THE PURPOSE OF INTERMEDIATE REVIEW ONLY. IT IS NOT TO BE USED FOR CONSTRUCTION, BIDDING OR PERMIT PURPOSES. ON NOVEMBER 30, 2023, IT IS NOT TO BE USED FOR ANY OTHER PURPOSES. KELLEY A. HELLER-VELA, P.E. 117398

**LONDON COVES SUBDIVISION**  
CORPUS CHRISTI, TEXAS

**MASTER DRAINAGE LAYOUT**

Y:\Land Development\Residential\Corpus Christi\London Coves - Rhoads\Autocad - files\Storm.dwg, 2/21/2024, 2:48:09 PM, DWG to PDF.ppt